
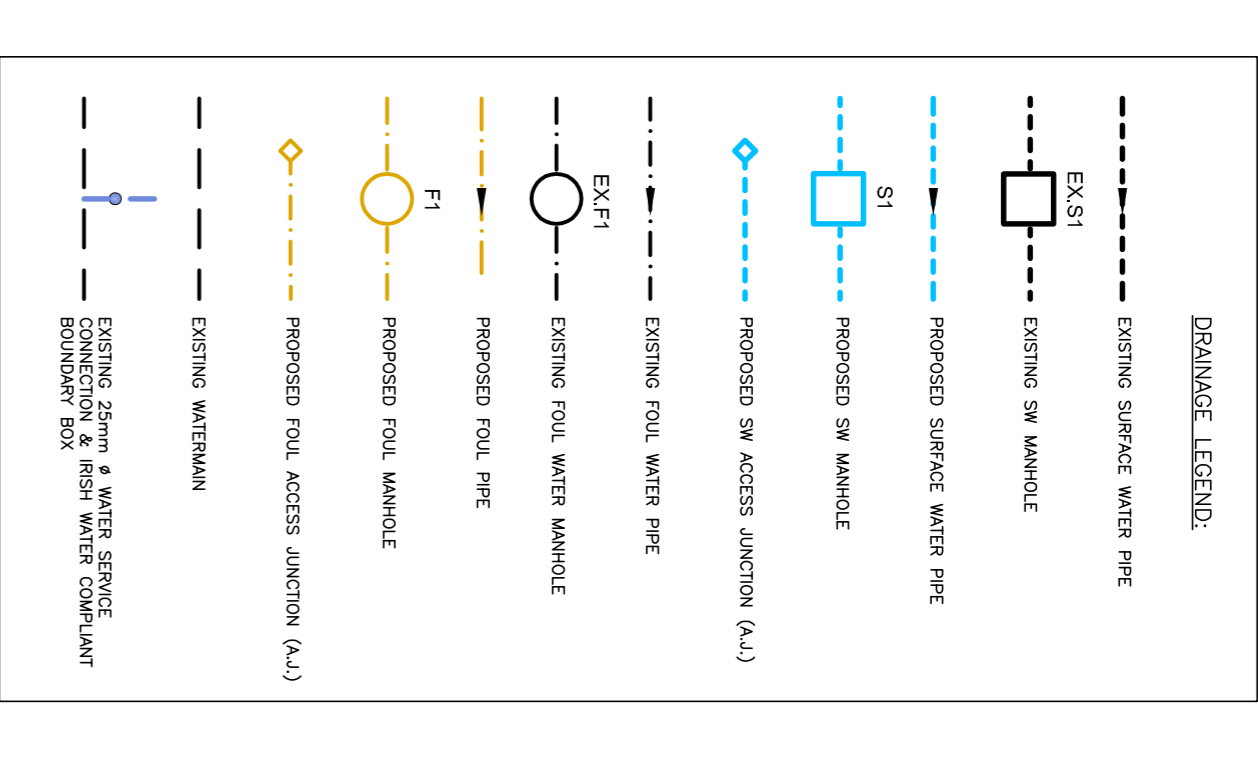


NOTES:
 OBA CONSULTING CIVIL & STRUCTURAL ENGINEERS
 CONSULTANTS AND MUST NOT BE REPRODUCED WITHOUT THEIR WRITTEN
 CONSENT.
 ALL DRAWINGS REMAIN THE PROPERTY OF THE CONSULTANTS.
 FIGURED DIMENSIONS ONLY TO BE TAKEN FROM THIS DRAWING.
 DO NOT SCALE TO BE CHECKED ON SITE.
 ALL DIMENSIONS TO BE INFORMED OF ANY DISCREPANCIES BEFORE WORK
 COMMENCES

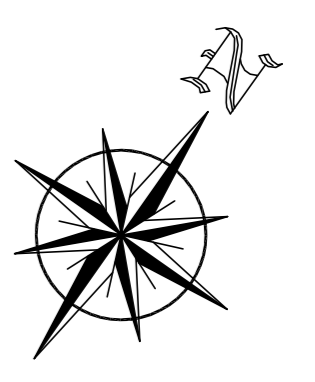

FOLL DRAIN


VALUE	CL	EL	L	DIST	PAVE	PIPE	DEPTH
NO	m	m	m	m	1/30	DIAMETER	mm
F1	59.000	56.870	17.0	100	0.45		
F1	57.070	57.170	23.800	17.0	100	0.50	
F2	52.460	55.240	11.800	30.0	100	0.50	
S1	59.300	55.018	54.424	13.000	100	1.40	

SW DRAIN

NO	CL	EL	L	DIST	PAVE	DEPTH
NO	m	m	m	m	1/30	DIAMETER
S1	59.000	54.525	59.455	13.200	91	0.45
S1	57.070	57.072	23.700	14.0	100	0.55
S2	57.160	56.000	55.048	5.400	13	1.65
TANK	59.300	52.134	52.134	11.200	30	1.55
S1	56.100	54.000	54.000	4.000	100	1.40
S1	57.700	54.078	54.078	1.500	100	2.25



SITE LAYOUT PLAN - DRAINAGE
 SCALE 1:150

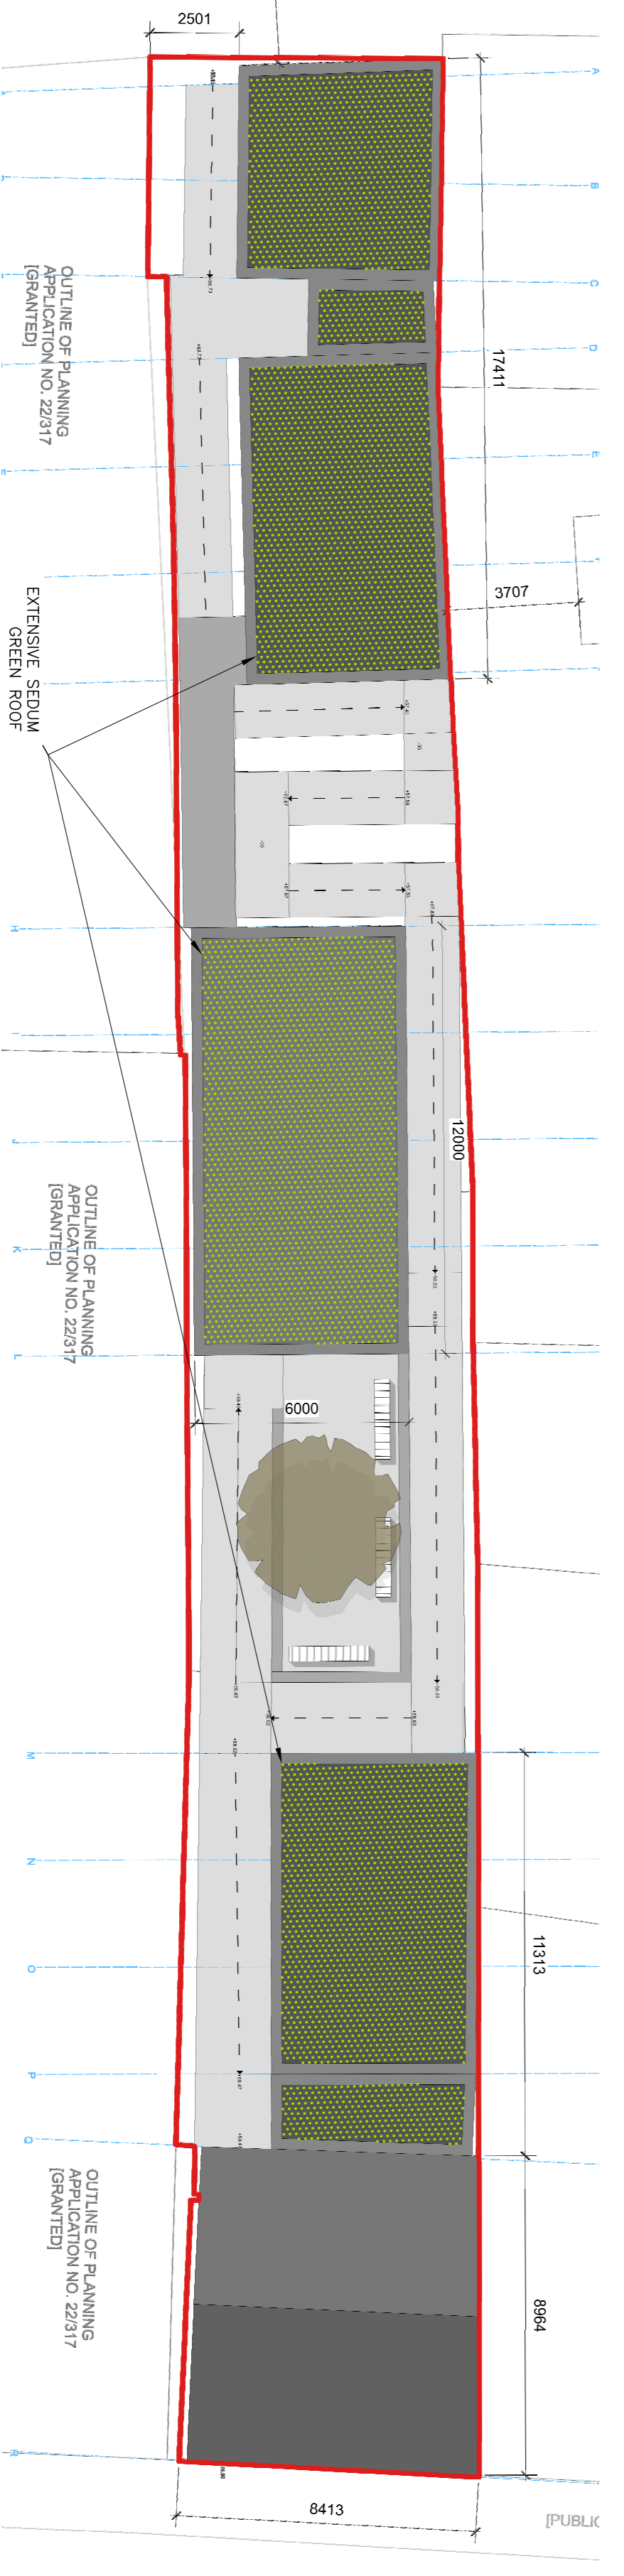

ROOF PLAN - DRAINAGE
 SCALE 1:150

Client	CAVAN COUNTY COUNCIL	By	CHM
Project Title	BELTURRETT COMMUNITY & ENTERPRISE HUB, BELTURRETT, CO. CAVAN	Date	JAN 2024
Drawing Title	FOUL & SURFACE WATER DRAINAGE & WATER CONNECTION LAYOUT PLAN	Drawn by	CHM
Architect	COONEY ARCHITECTS	Drawing Status	PLANNING
Scale	1:100@A1	Job Number	99-07
Drawn by	CHM	Drawing No.	C01

The Social Foot
 1, Garden Street
 Limerick, Ireland
 Tel: 051 853000
 www.obaconsulting.ie
 E: cavan@obaconsulting.ie

OBA CONSULTING CIVIL & STRUCTURAL ENGINEERS